




SCALE: 1"=60'

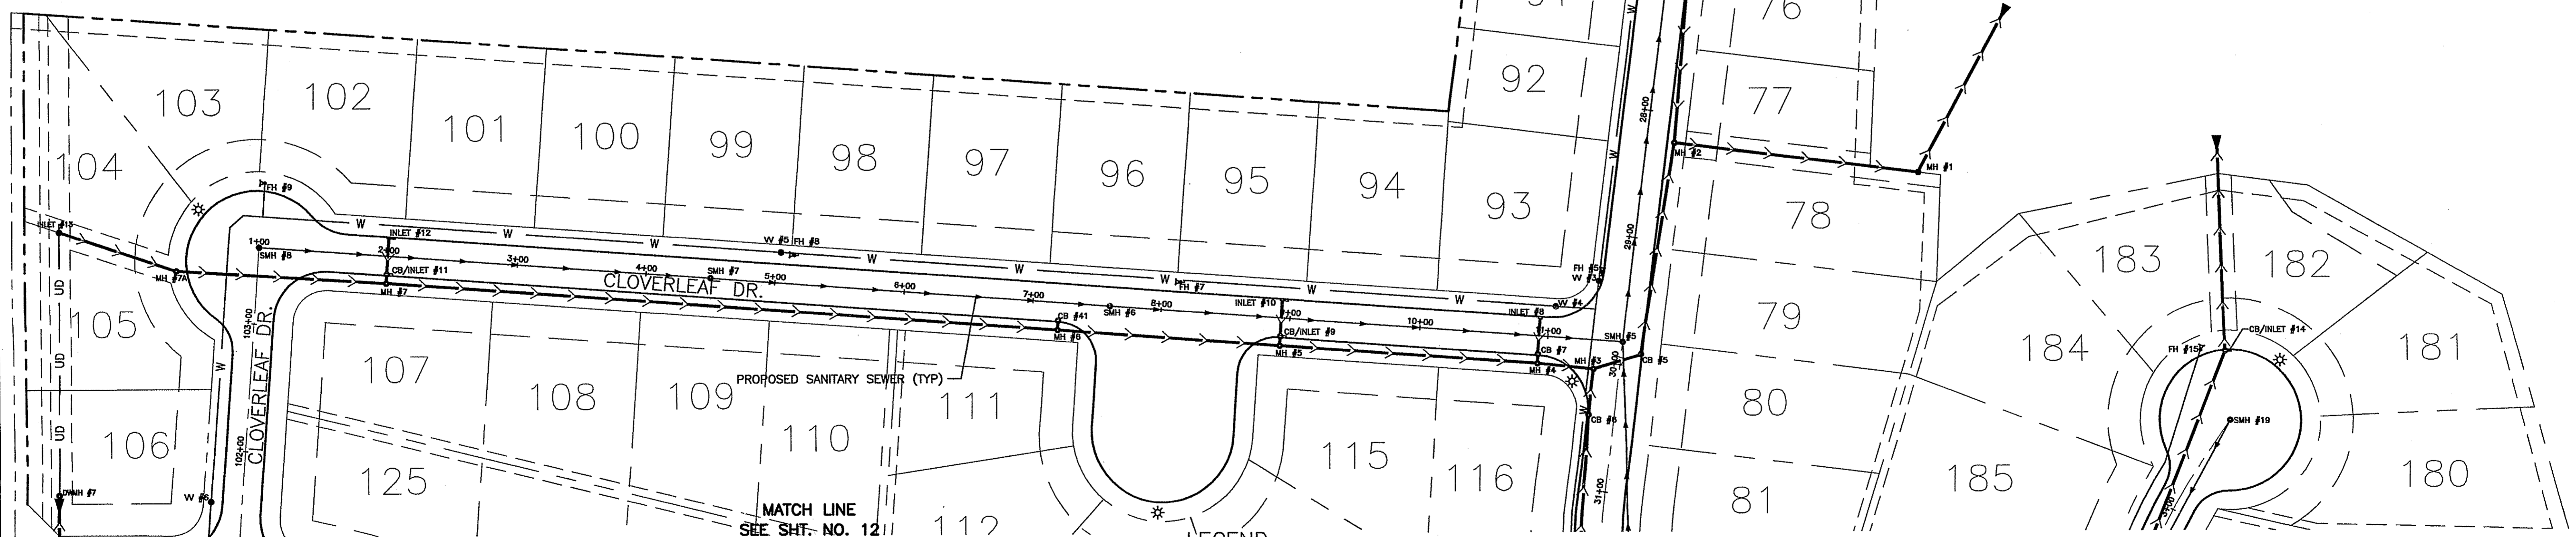

MATCH LINE
SEE SHT. NO. 12

LEGEND

- w — WATERMAIN
- s — SANITARY SEWER
- S — STORM SEWER
- UD — UNDERDRAIN
- * STREET LIGHTS
- ⊙ SMH SANITARY MANHOLE
- ⊙ MH STORM MANHOLE
- ⊙ CB CATCH BASIN
- ⊞ INLET CURB INLET
- ⊙ W VALVE AND VAULT
- ⊙ DWMH DRY WELL MANHOLE


UTILITY PLAN-NORTH
BROOKSIDE MEADOWS PLAT 3

REVISIONS		DATE	BY
⚠	06/16/2006	PER CITY COMMENTS	CM
⚠	07/10/2006	PER OWNER COMMENTS	JMR
⚠	01/30/2007	PER COUNTY COMMENTS	DLC

ISSUE DATE: 04/04/2006
 PROJECT NO.: 290E
 SHEET NO.: 11 OF 34

CARROLL ENGINEERING & ASSOCIATES, P.C.
 111 W. HURLBUT AVE. BELVIDERE, IL
 TELEPHONE (815) 547-3406

NOTE: LOCATIONS OF UNDERGROUND UTILITIES ARE TAKEN FROM RECORD INFORMATION AND ARE APPROXIMATE. CALL J.U.L.I.E. AT 1-800-892-0123, BEFORE DIGGING, TO OBTAIN FIELD LOCATIONS.

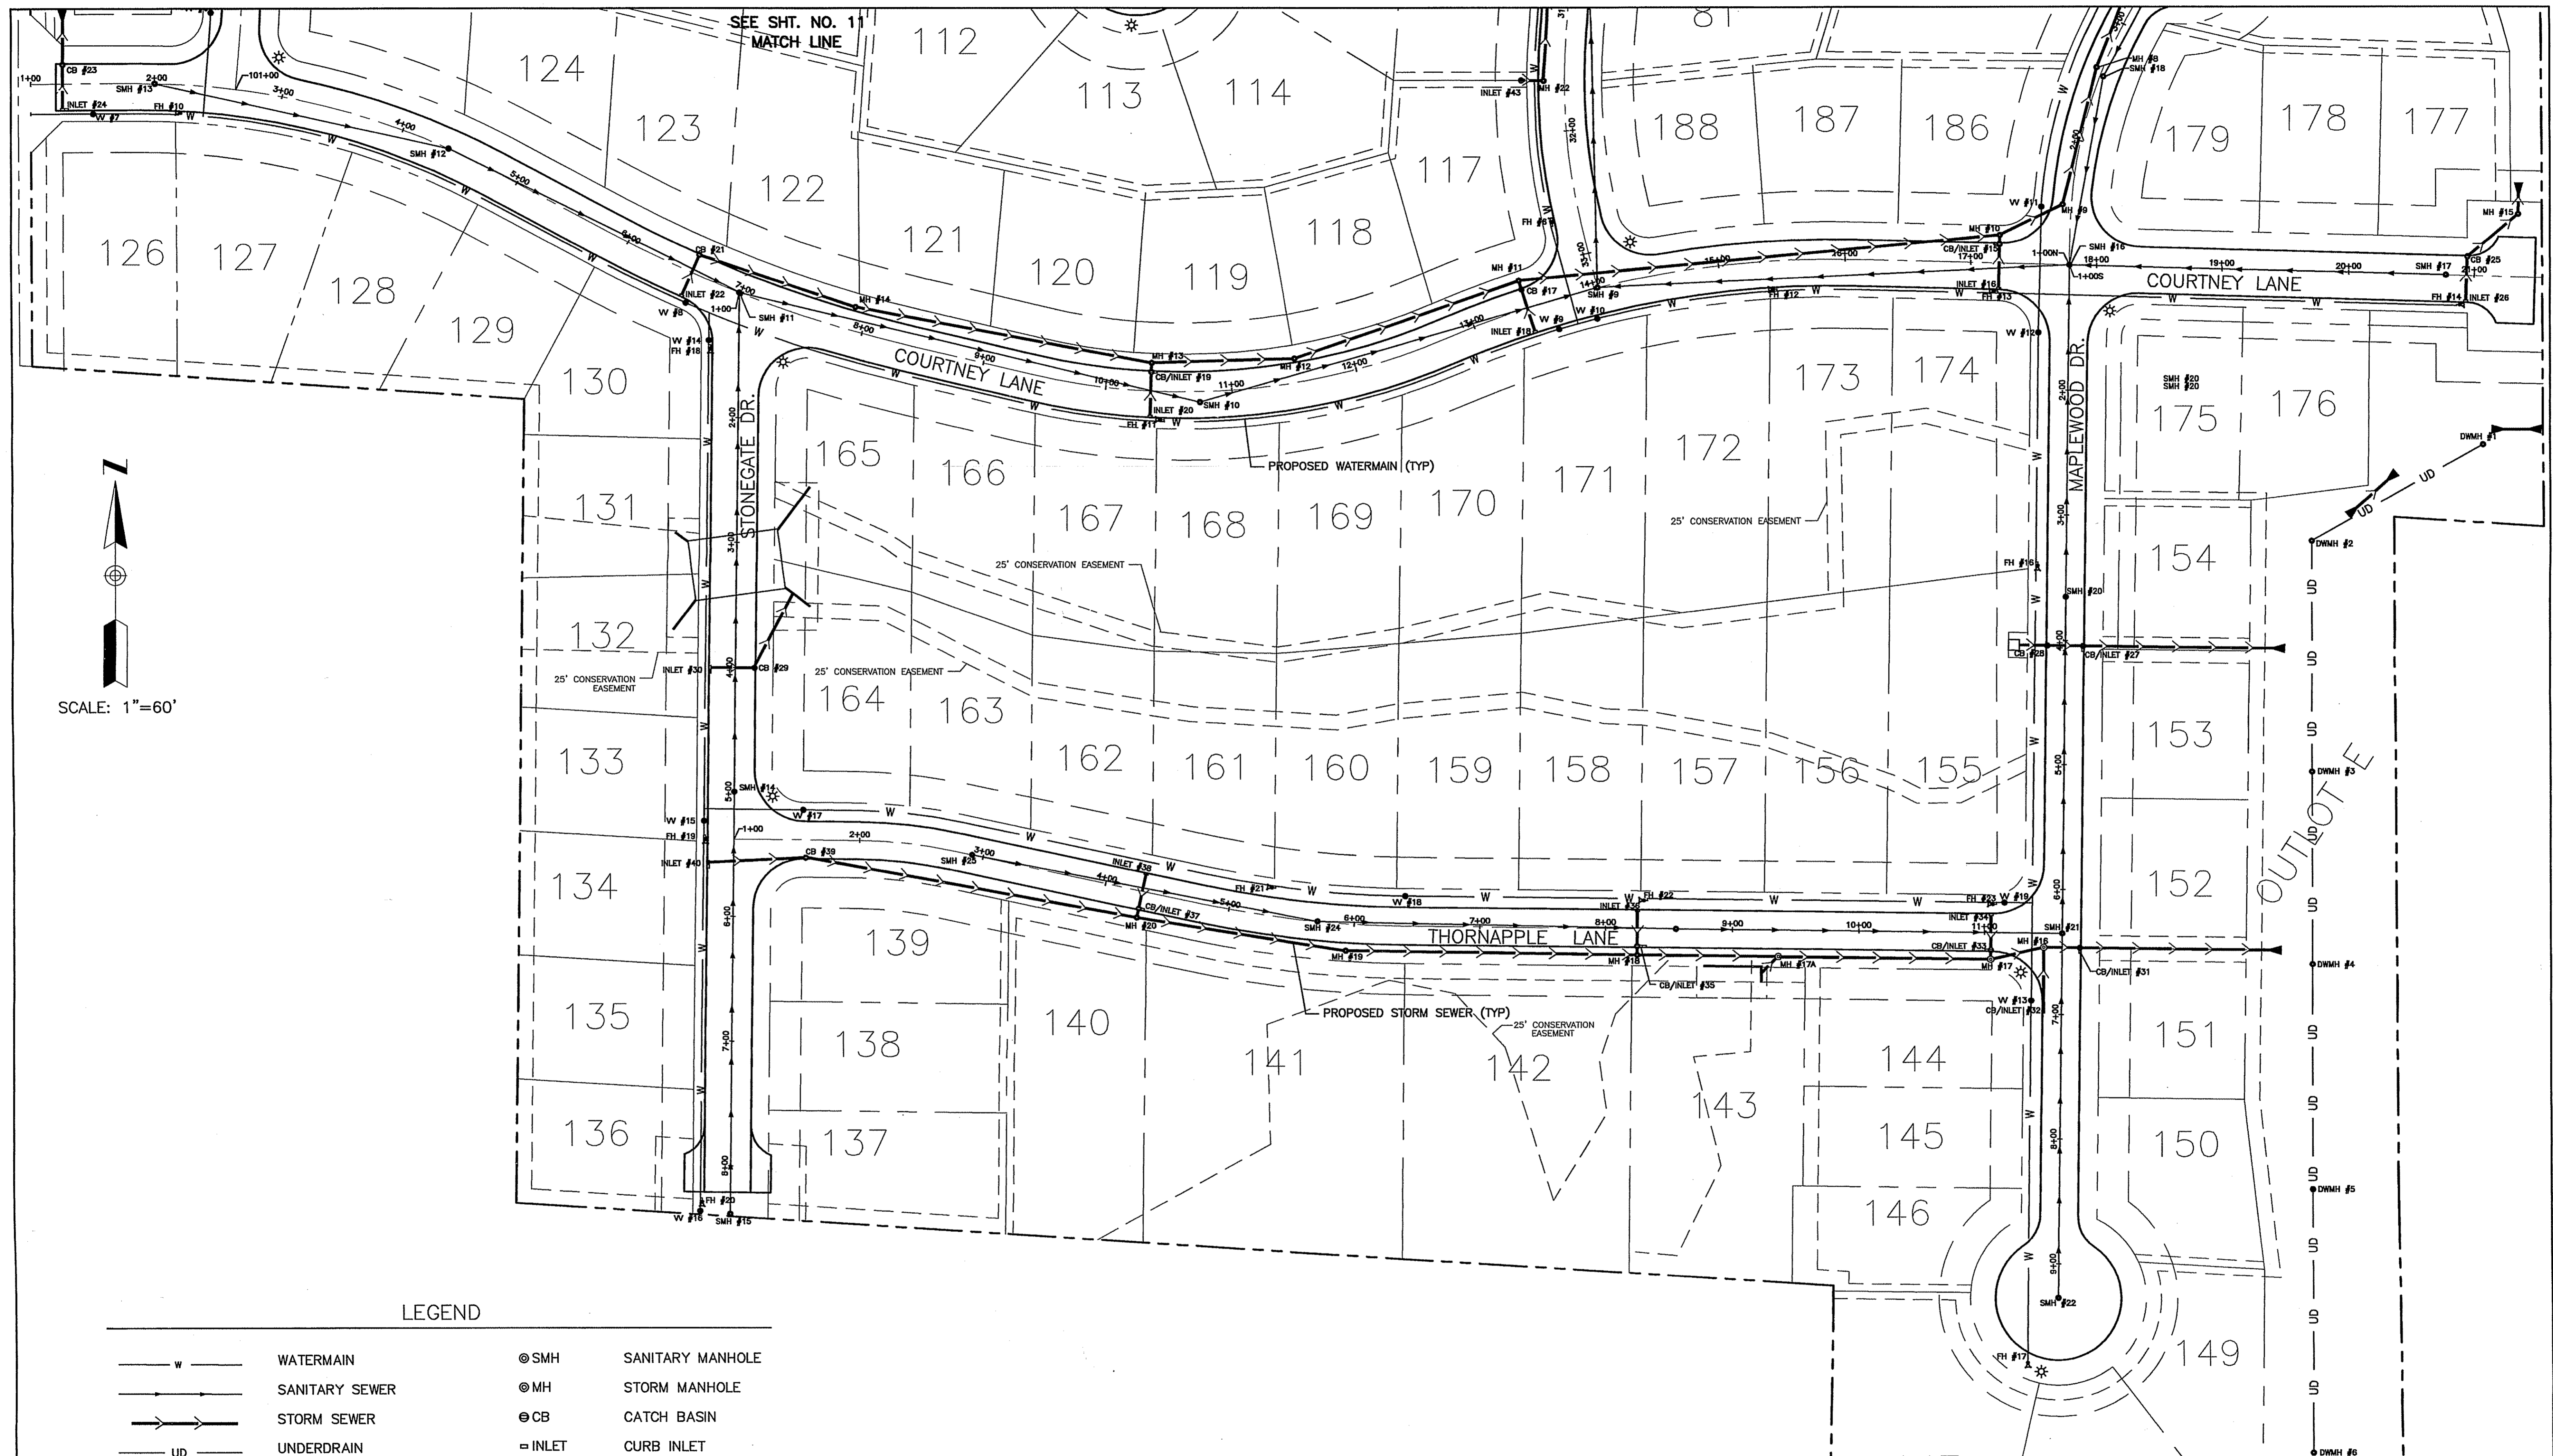

LEGEND

- | | | | |
|--------|----------------|---------|------------------|
| — W — | WATERMAIN | ⊙ SMH | SANITARY MANHOLE |
| — S — | SANITARY SEWER | ⊙ MH | STORM MANHOLE |
| —>—> | STORM SEWER | ⊙ CB | CATCH BASIN |
| — UD — | UNDERDRAIN | = INLET | CURB INLET |
| * | STREET LIGHTS | ⊙ W | VALVE AND VAULT |
| | | ⊙ DWMH | DRY WELL MANHOLE |

NOTE:
LOCATIONS OF UNDERGROUND UTILITIES ARE TAKEN FROM
RECORD INFORMATION AND ARE APPROXIMATE. CALL
J.U.L.I.E. AT 1-800-892-0123, BEFORE DIGGING, TO
OBTAIN FIELD LOCATIONS.

UTILITY PLAN—SOUTH
BROOKSIDE MEADOWS PLAT 3

REVISIONS		DRAFTED BY:	CM
△	06/16/2006	PER CITY COMMENTS	JMR
△	07/10/2006	PER OWNER COMMENTS	DLC
△	01/30/2007	PER COUNTY COMMENTS	04/04/2006
		PROJECT NO.:	290E
		SHEET NO.:	12 OF 34

CARROLL ENGINEERING & ASSOCIATES, P.C.
111 W. HURLBUT AVE. BELVIDERE, IL
TELEPHONE (815) 547-3406